
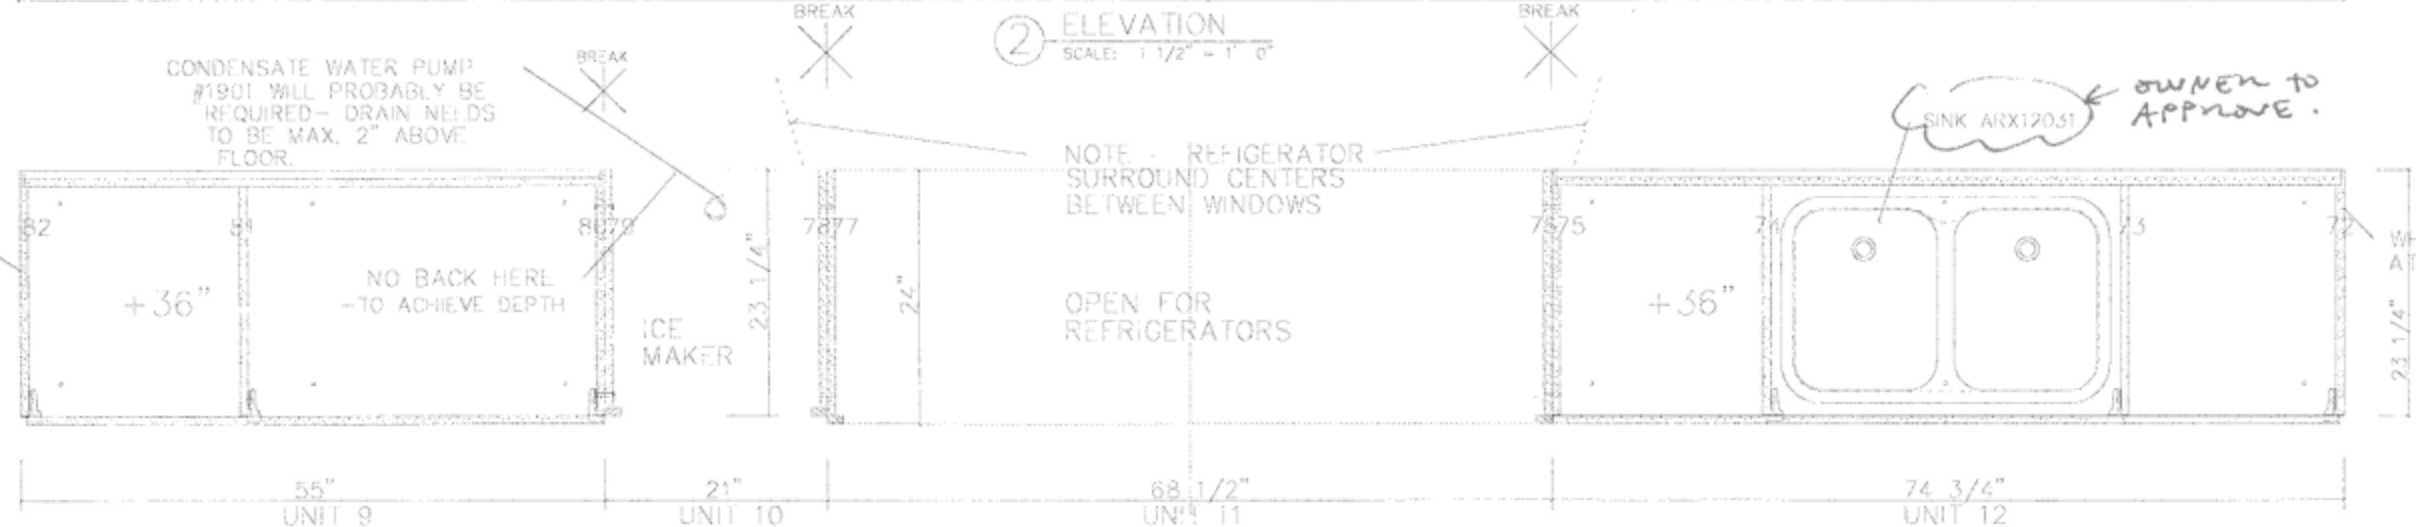


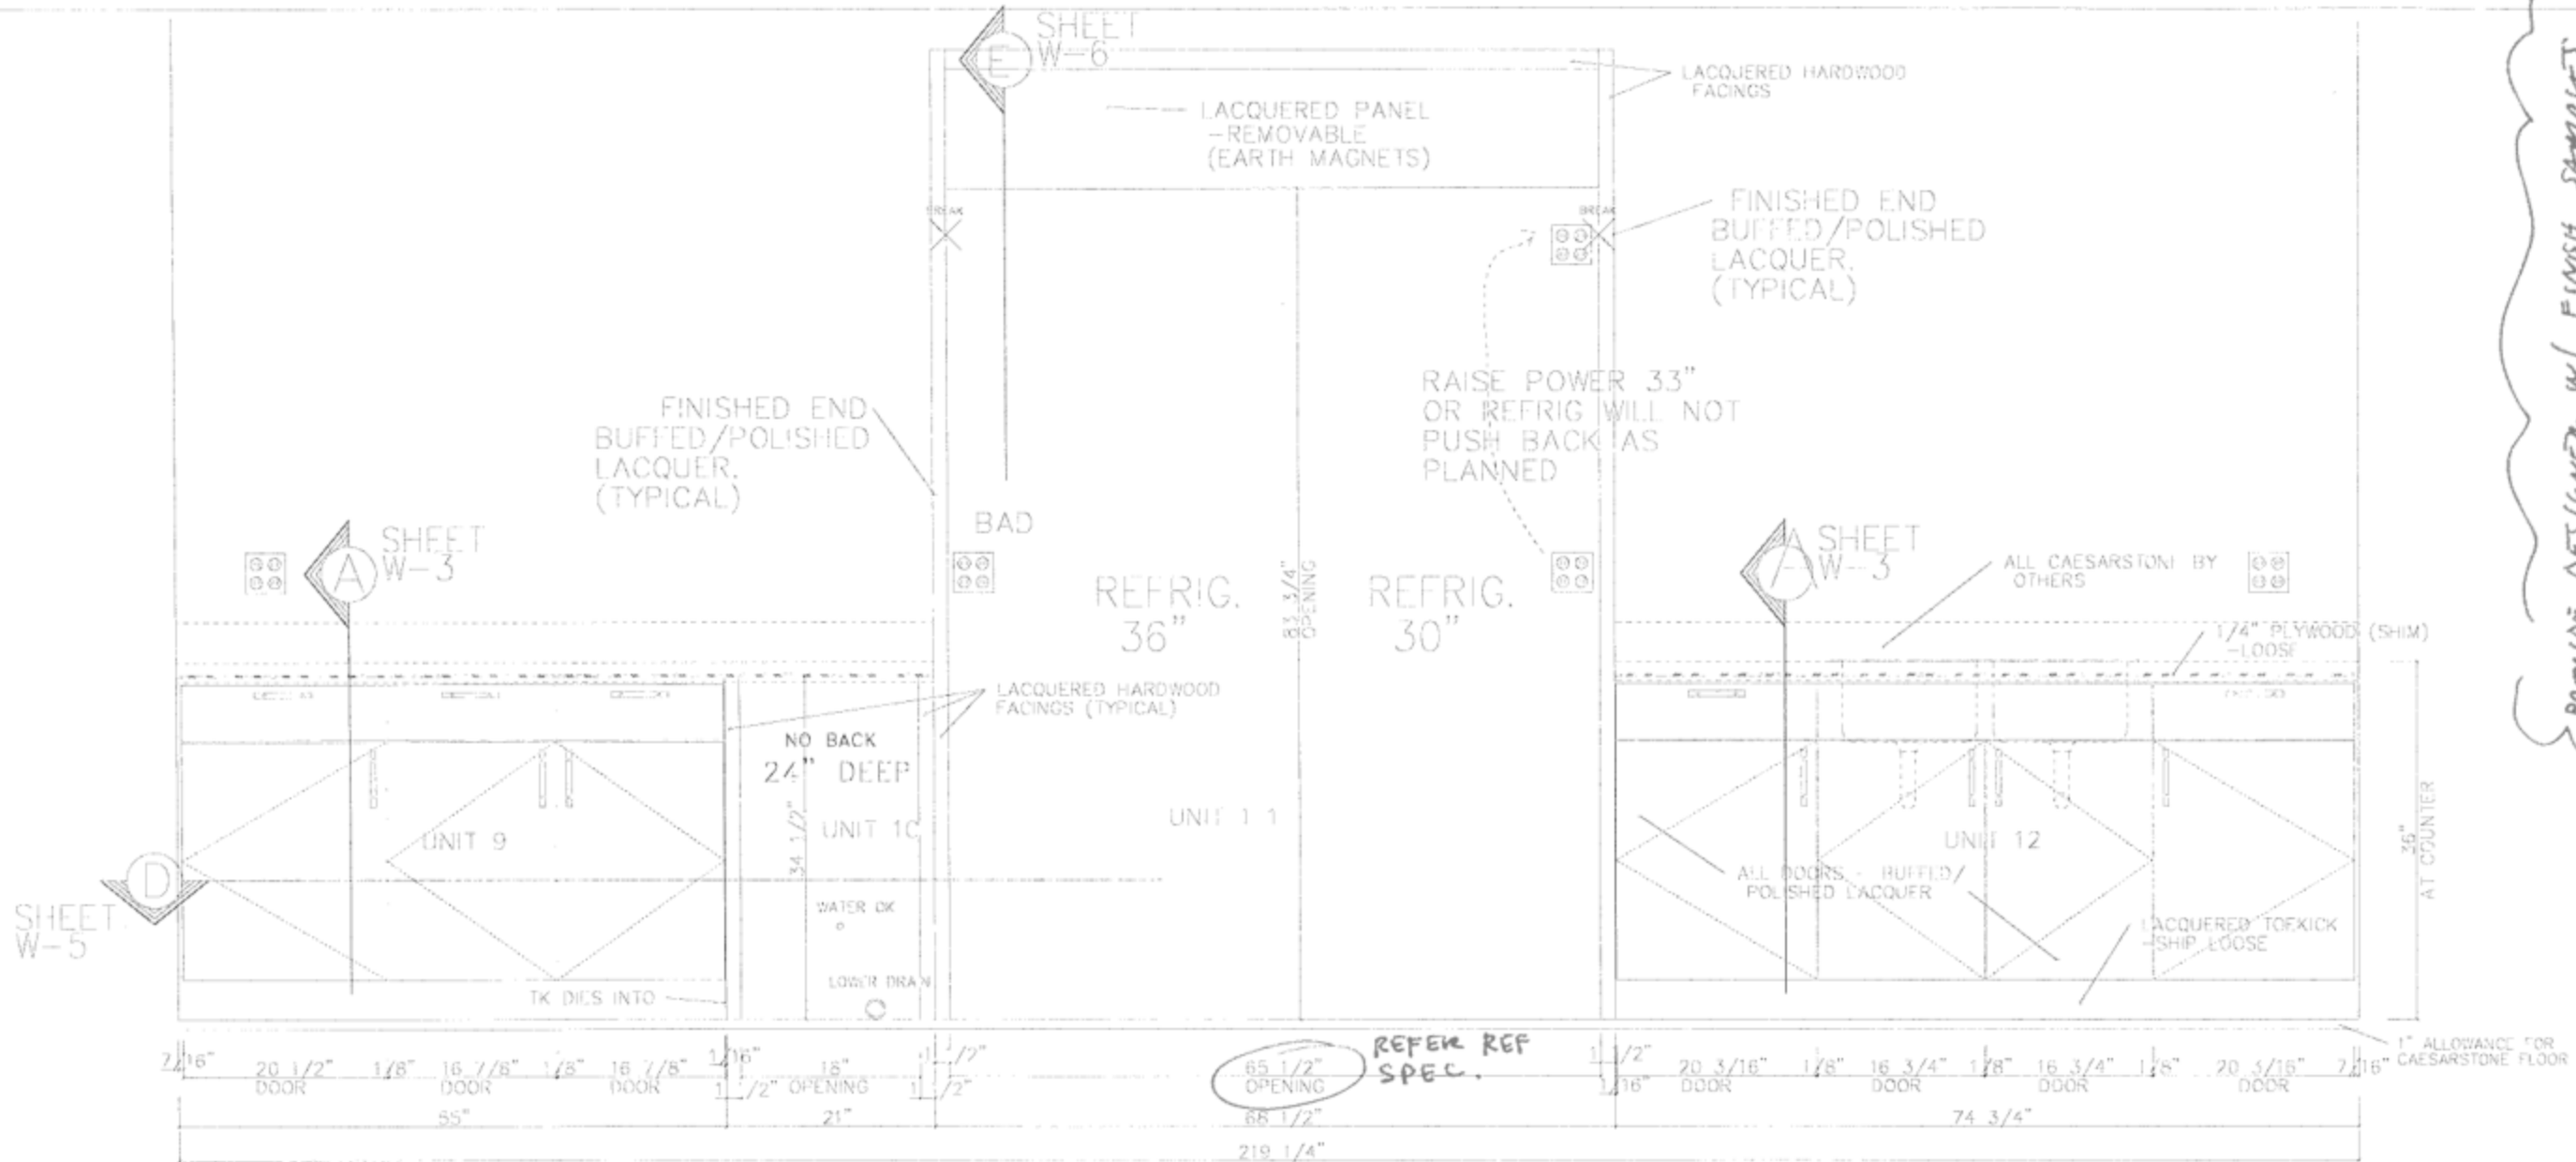

ALL CABINET INTERIORS - WHITE MELAMINE
ALL CABN'T EXTERIORS - POLISHED LACQUER

① PLAN / SECTION
SCALE: 1 1/2" = 1' 0"




SCALE: AS NOTED
DRAWN BY: KAS

PROJECT: LITTLE ST. JAMES
SHEET TITLE: KITCHEN ELEV./SECTION
SHEET 5 OF 9

REVISED: DATE: 10/25/10
SHEET #: W-5

PROVIDE DESIGNER W/ FINISH SAMPLES
FOR APPROVAL PRIOR TO FABRICATION
OWNER TO APPROVE APPLIANCES
& PLUMBING FIXTURES.

APPROVED AS NOTED 11.10.2010
MARK REFF

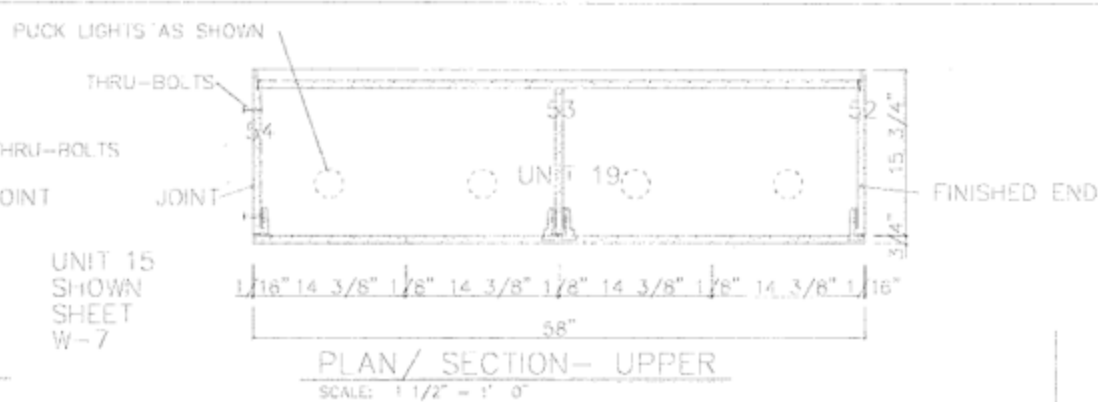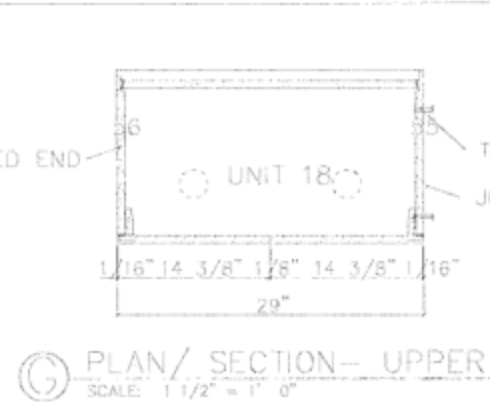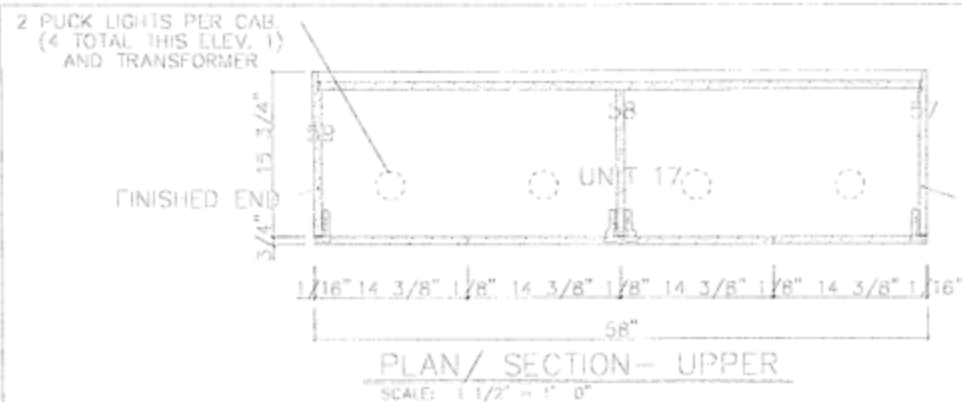

PROVIDE DESIGNER W/ FINISH
SAMPLES FOR APPROVAL
PRIOR TO FABRICATION

OWNER TO APPROVE
ALL APPLIANCES.

☐ APPROVED
☐ REJECTED
☐ EXAMINED

☒ APPROVED AS NOTED
☐ REVISE AND RESUBMIT
☐ SUBMIT SPECIFIED ITEM

CHECKING IS ONLY FOR GENERAL CONFORMANCE WITH THE DESIGN CONCEPT OF THE PROJECT AND GENERAL COMPLIANCE WITH THE INFORMATION GIVEN IN THE CONTRACT DOCUMENTS. CONTRACTOR IS RESPONSIBLE FOR DIMENSIONS WHICH SHALL BE CONFIRMED AND CORRELATED AT THE JOB SITE; FABRICATION PROCESSES AND TECHNIQUES OF CONSTRUCTION, AND COORDINATION OF THIS WORK WITH THE WORK OF ALL OTHER TRADES. ALL WOOD TO BE FIRE TREATED/RETARDANT TO MEET FIRE RATING AS PER LOCAL, STATE AND FEDERAL CODE.


- MARKZEFF -

11.10.2010

DATE

REF#

SIGNATURE

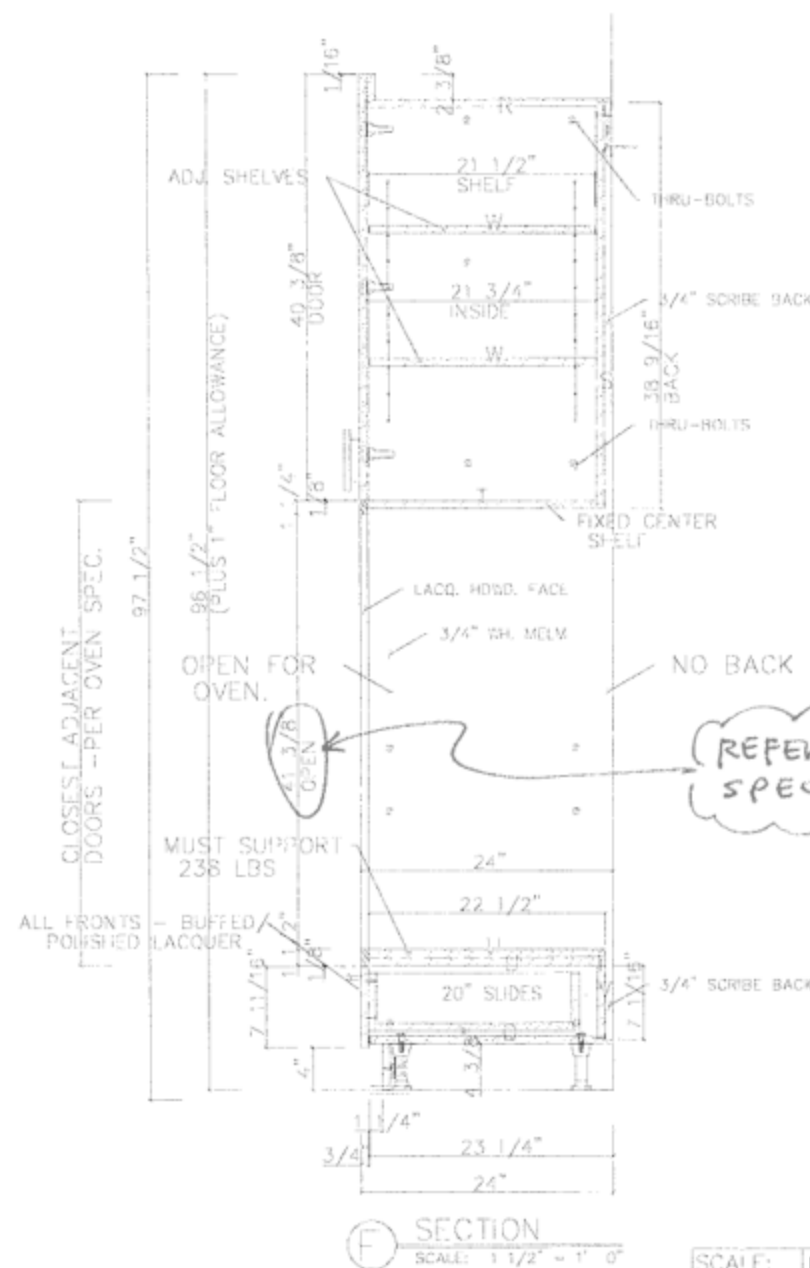


REMOVABLE LACQUERED PANEL
(ON EARTH MAGNETS)
- RUN DOWN 1/16\" SO PANEL
RECESSES 1/16\".
- REBATE AT BOTTOM LETS
WEB FRAME CARRY WEIGHT
AND SUPPORT VERTICALLY.

LACQUERED HARDWOOD
FACINGS (TYPICAL)

OUTSIDE ENDS ARE
BUFFED/POLISHED
LACQUER.
(TYPICAL)

REFER OVEN
SPEC.

REFER REFRIGERATOR
SPECIFICATIONS

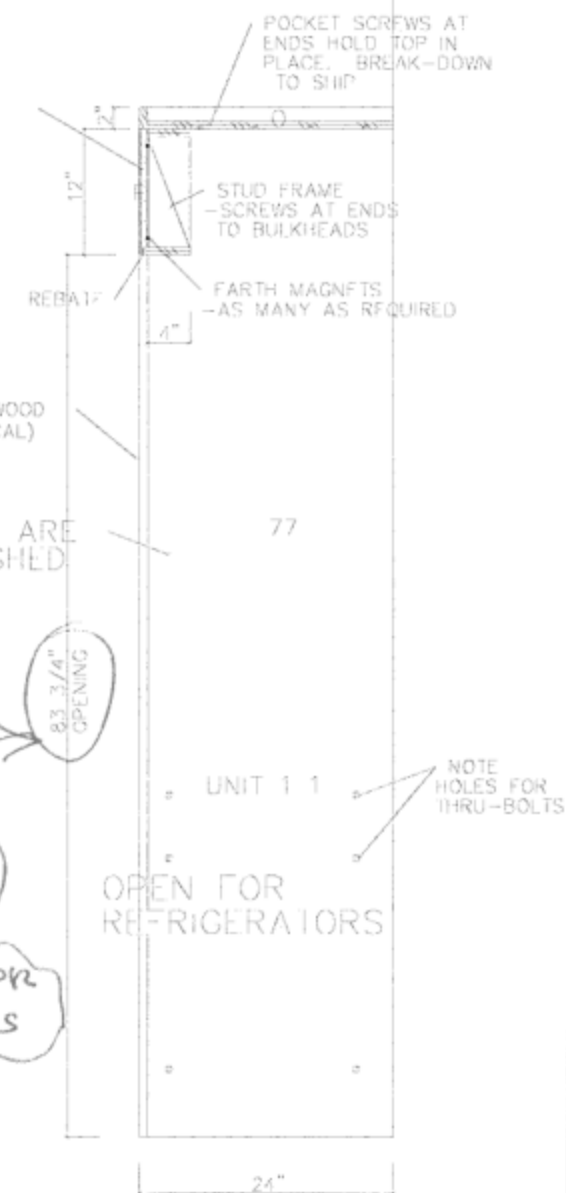

ALL CABINET INTERIORS -- WHITE MELAMINE
ALL CABN'T EXTERIORS -- POLISHED LACQUER

SCALE:

AS NOTED
DRAWN BY

KAS



PROJECT: UTILE ST. JAMES

SHEET TITLE:

KITCHEN SECTIONS

SHEET 6 OF 9


REVISED:

DATE:

10/25/10


SHEET #:

W-6

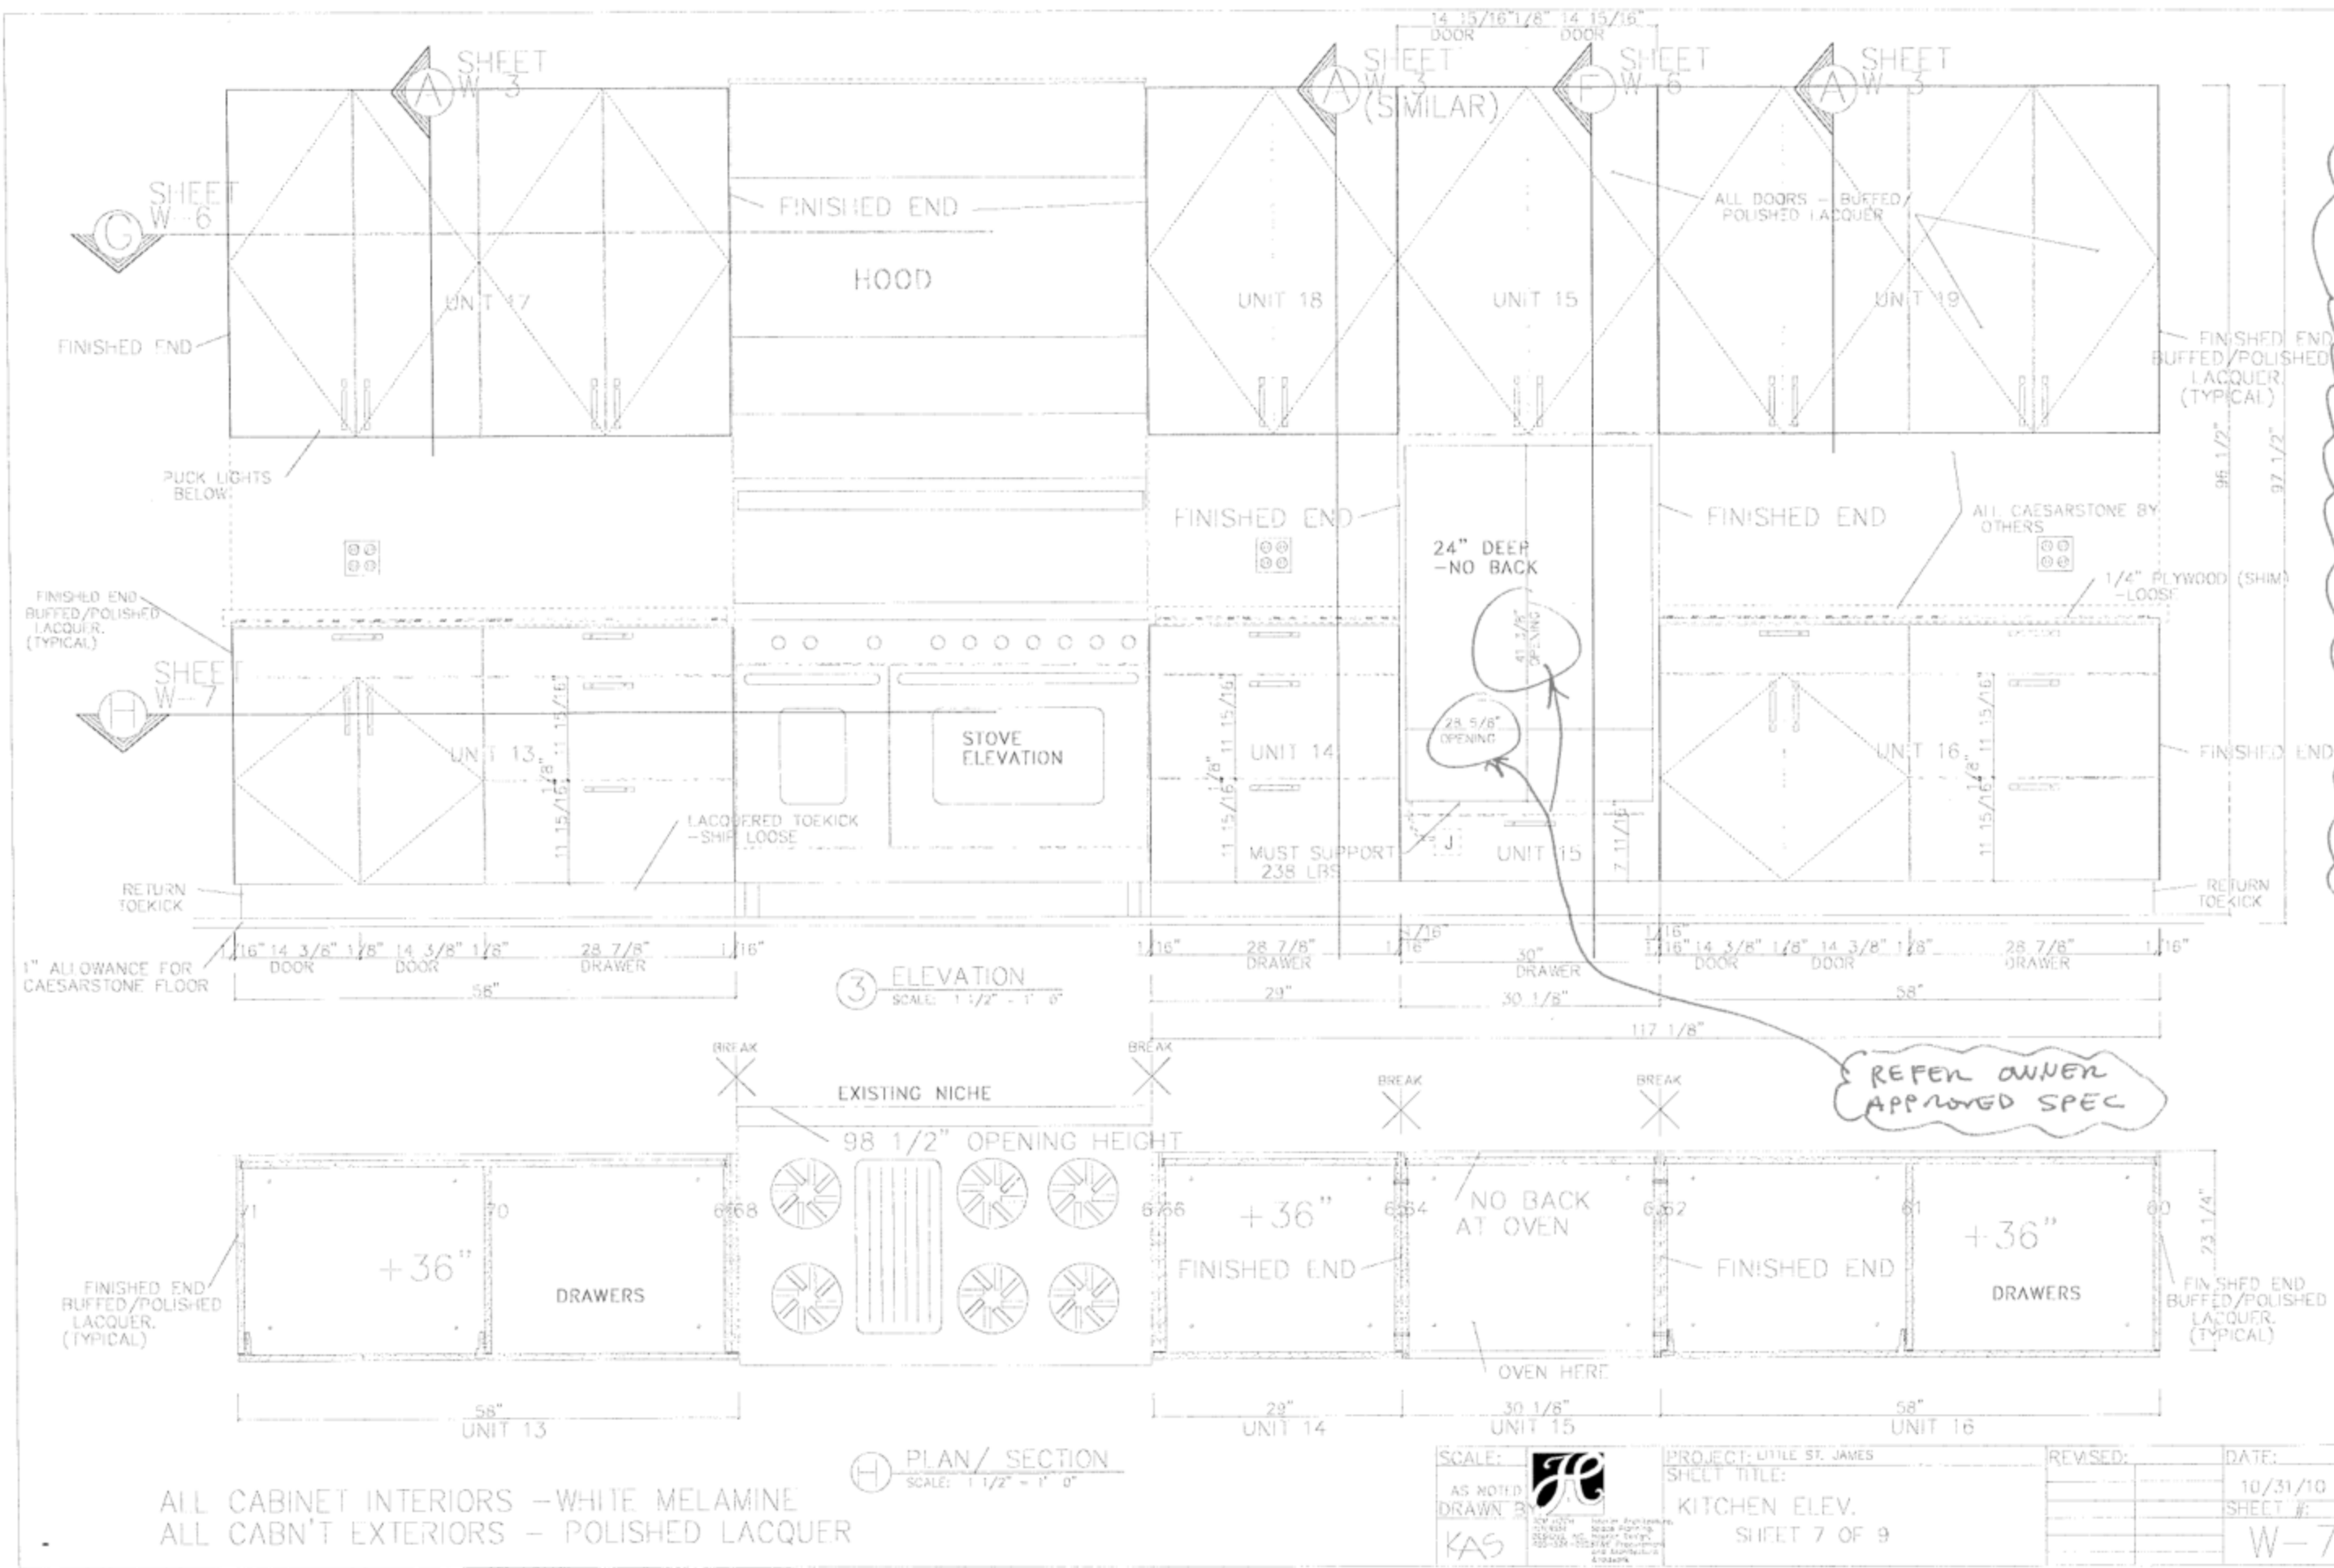


PROVIDE DESIGNER W/ FINISH SAMPLES FOR APPROVAL PRIOR TO FABRICATION.
OWNER TO APPROVE ALL APPLIANCES


K. APPROVED 11.10.2010
JL MARK ZEFF.

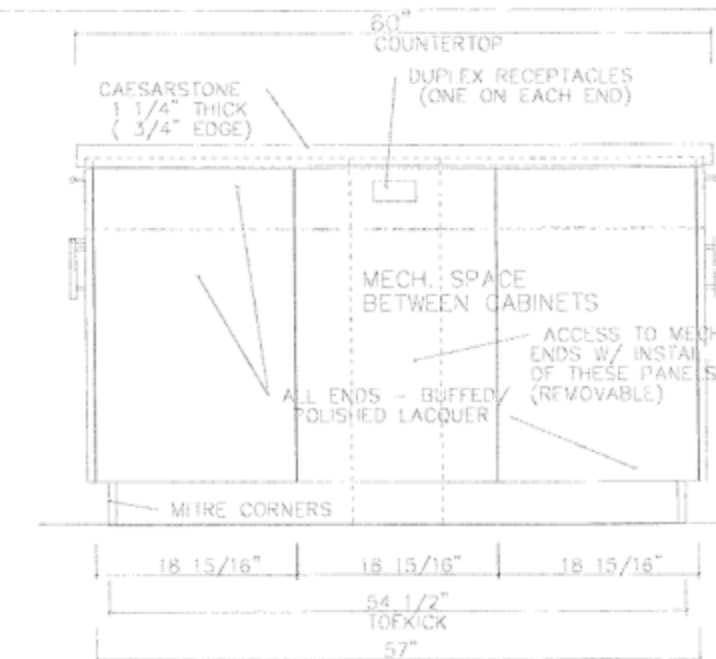

5 ELEVATION
SCALE: 1 1/2" = 1' 0"

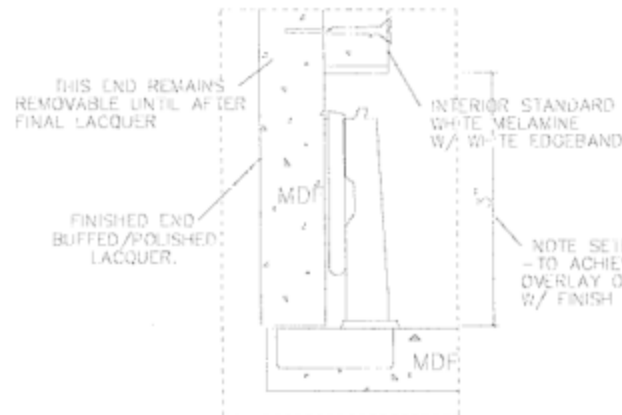



EE DETAIL
SCALE: FULL SIZE

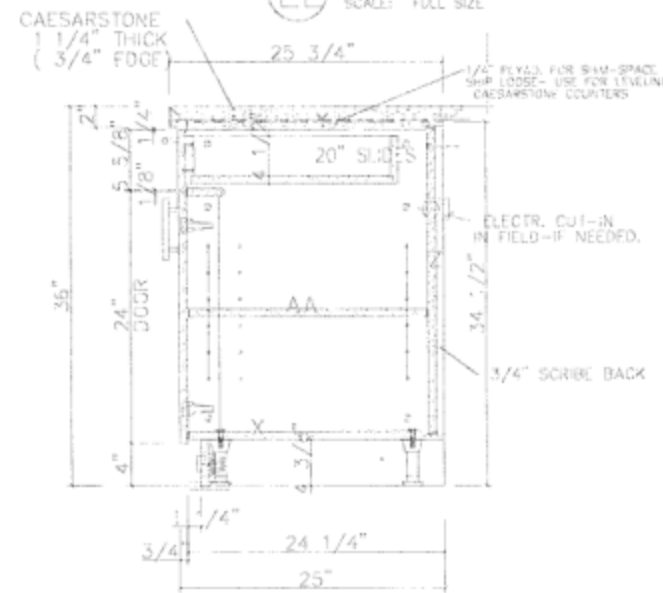


1 SECTION
SCALE: 1 1/2" = 1' 0"

ALL CABINET INTERIORS - WHITE MELAMINE
ALL CABN'T EXTERIORS - POLISHED LACQUER

NOTE -
WILL ISLAND BE OK 11 1/4" LONGER?
DOUBLE WASTE BIN SOFT-CLOSE GLIDES
REQUIRE MINIMUM 15 1/4" OPENING.

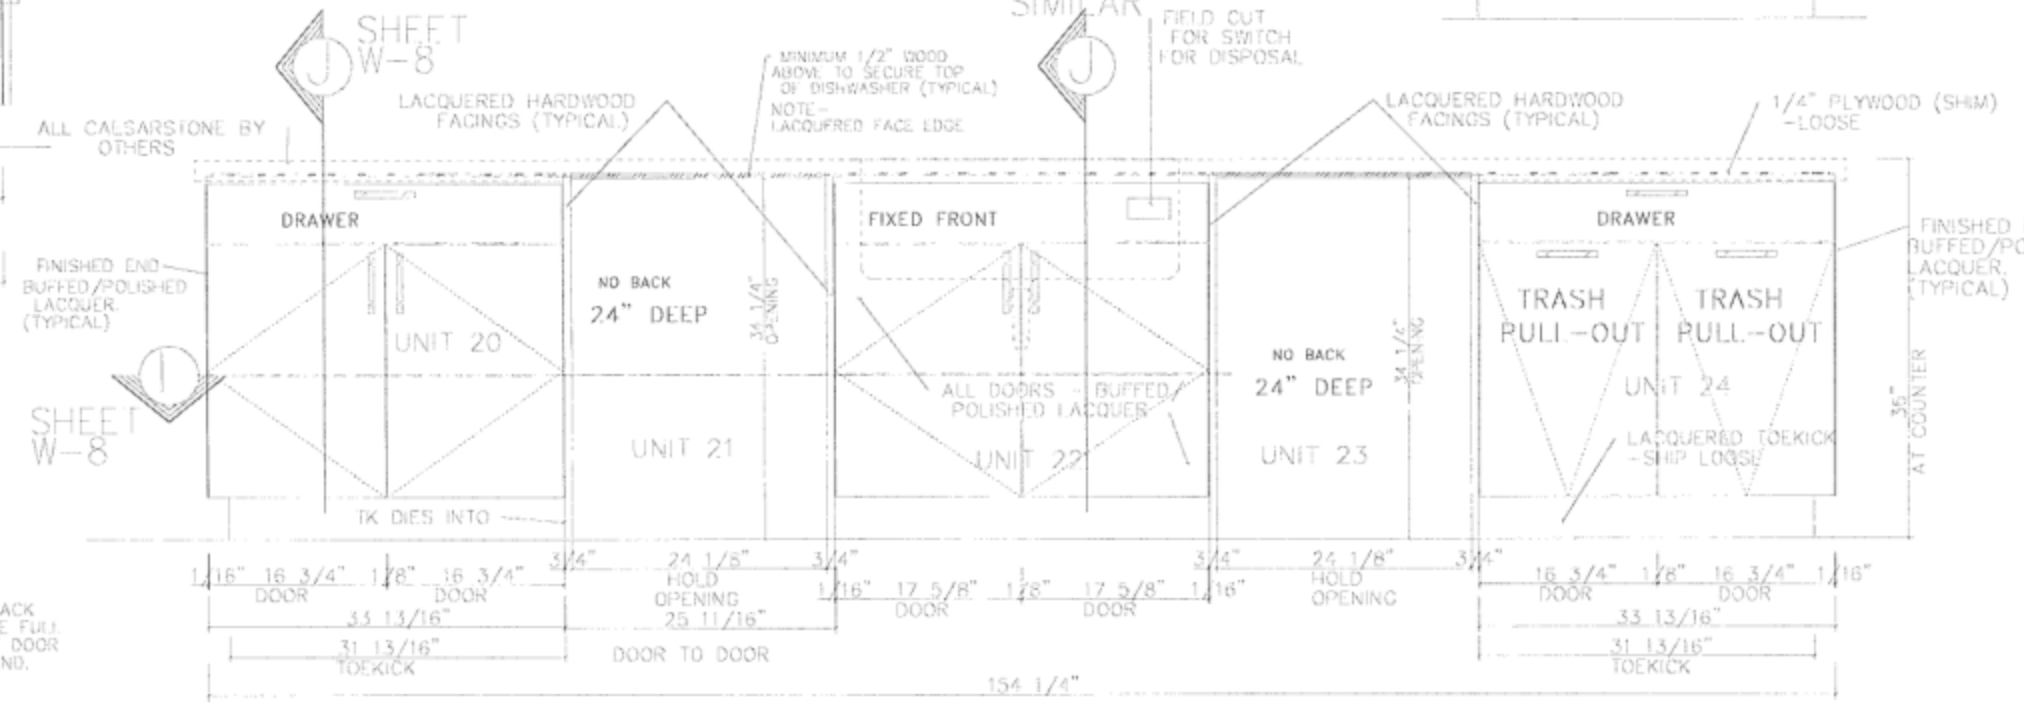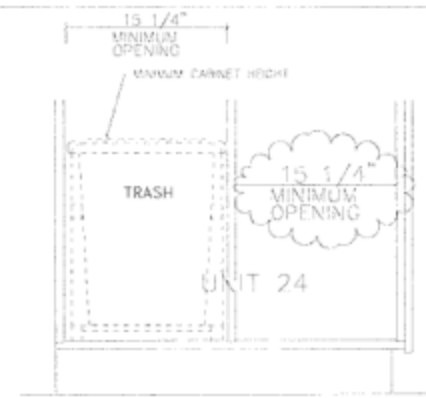

4 ELEVATION
SCALE: 1 1/2" = 1' 0"




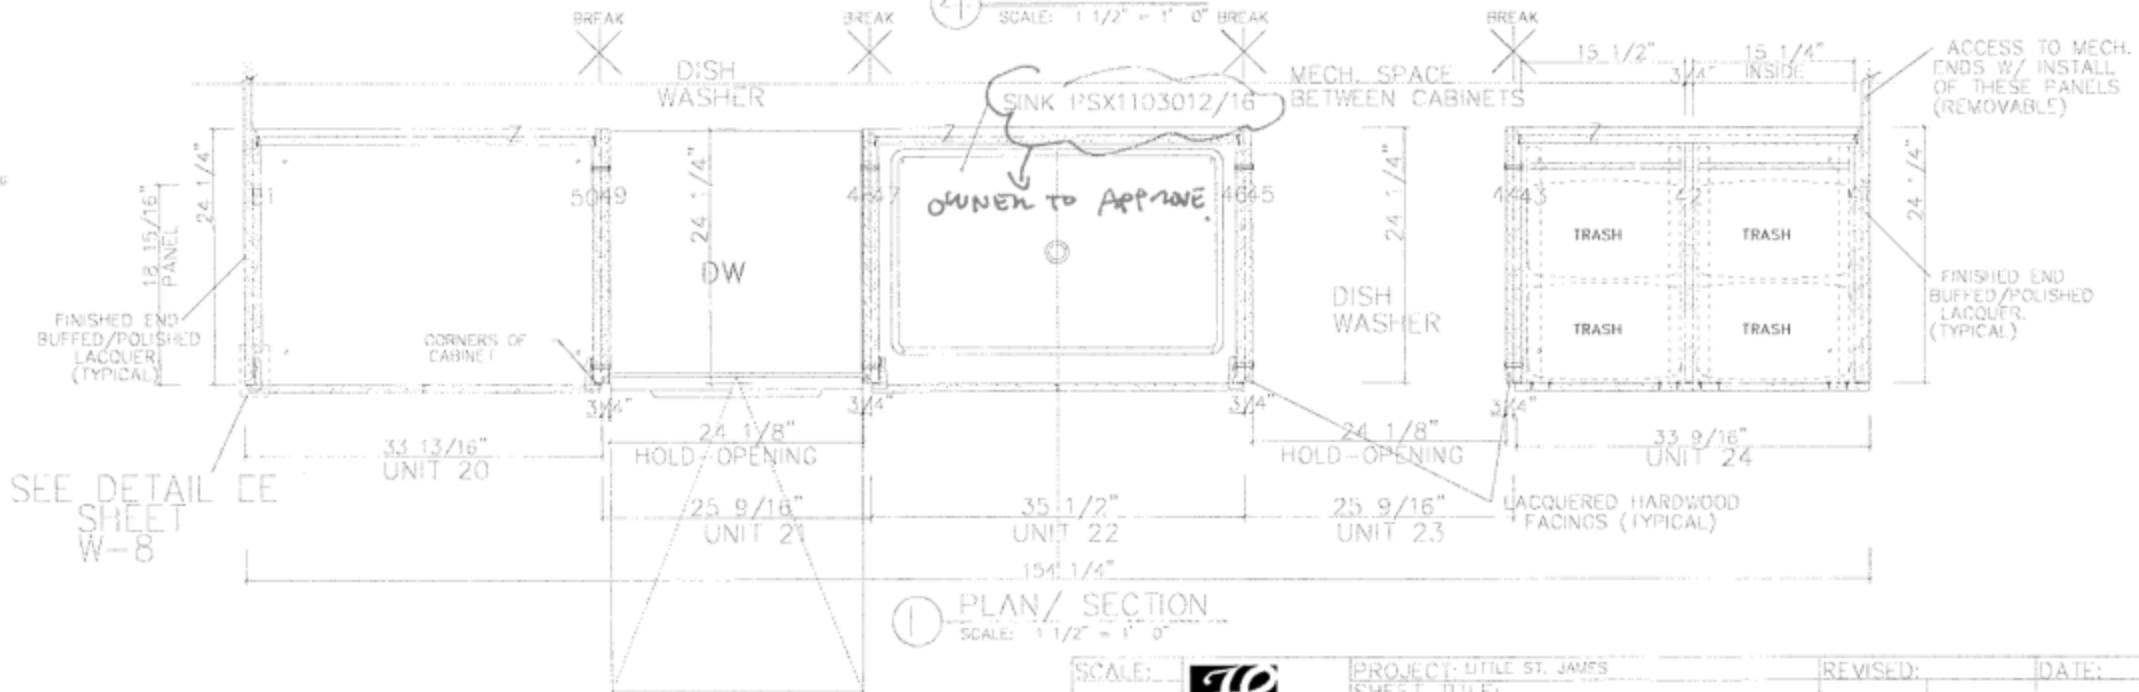


1 PLAN/SECTION
SCALE: 1 1/2" = 1' 0"

SCALE: AS NOTED DRAWN BY KAS	PROJECT: UTILE ST. JAMES SHEET TITLE: ISLAND ELEV./SECTION SHEET 8 OF 9	REVISED:	DATE: 10/25/10 SHEET #: W-8
------------------------------	---	----------	--------------------------------

PROVIDE DESIGNER W/ FINISH SAMPLES
FOR APPROVAL PRIOR TO FABRICATION
OWNER TO APPROVE PLUMBING SPEC.

APPROVED 10.11.2010
MARK ZEFF

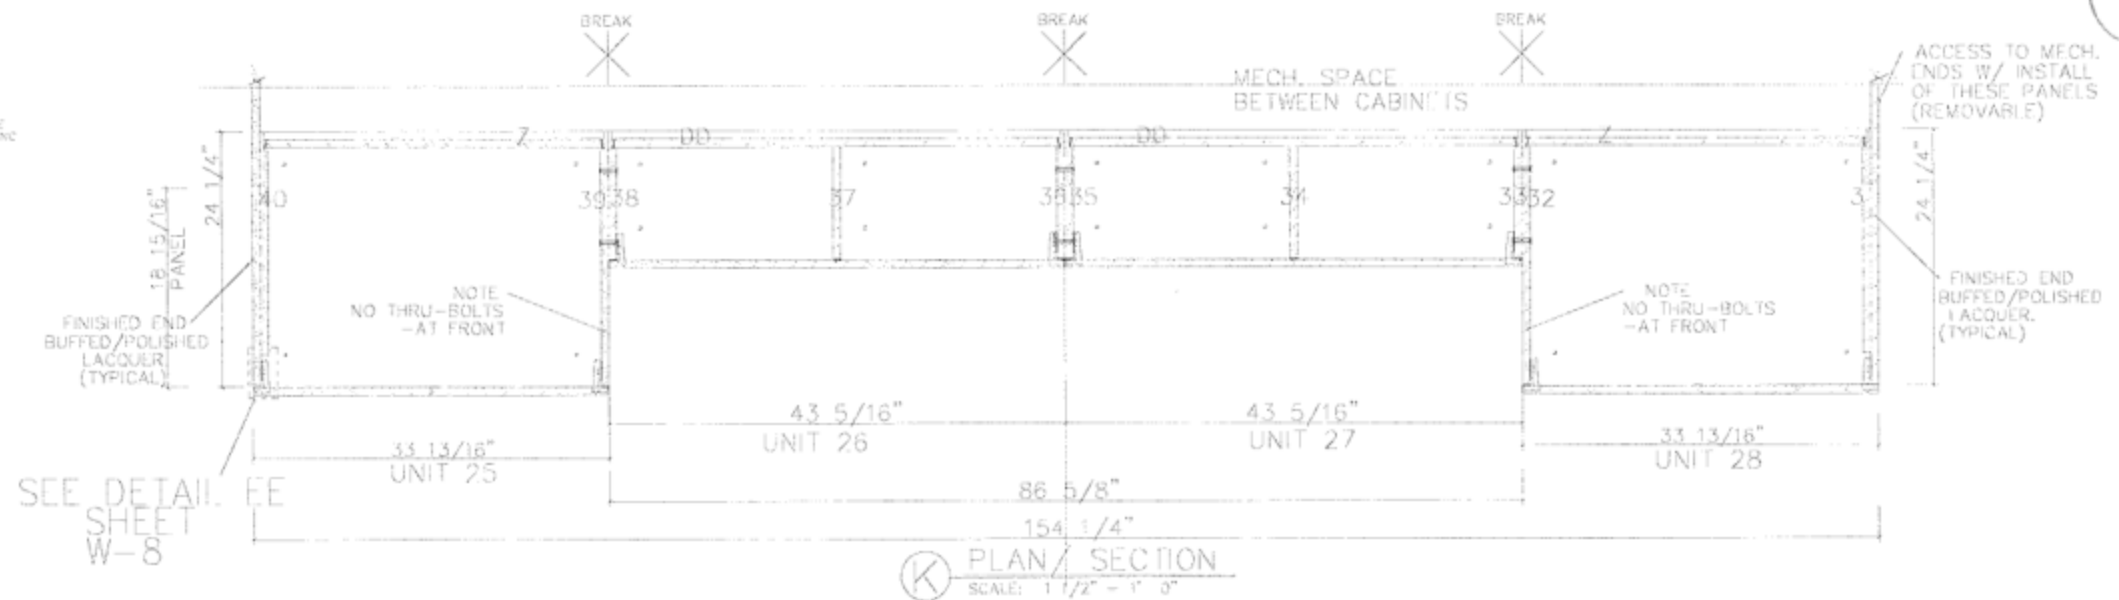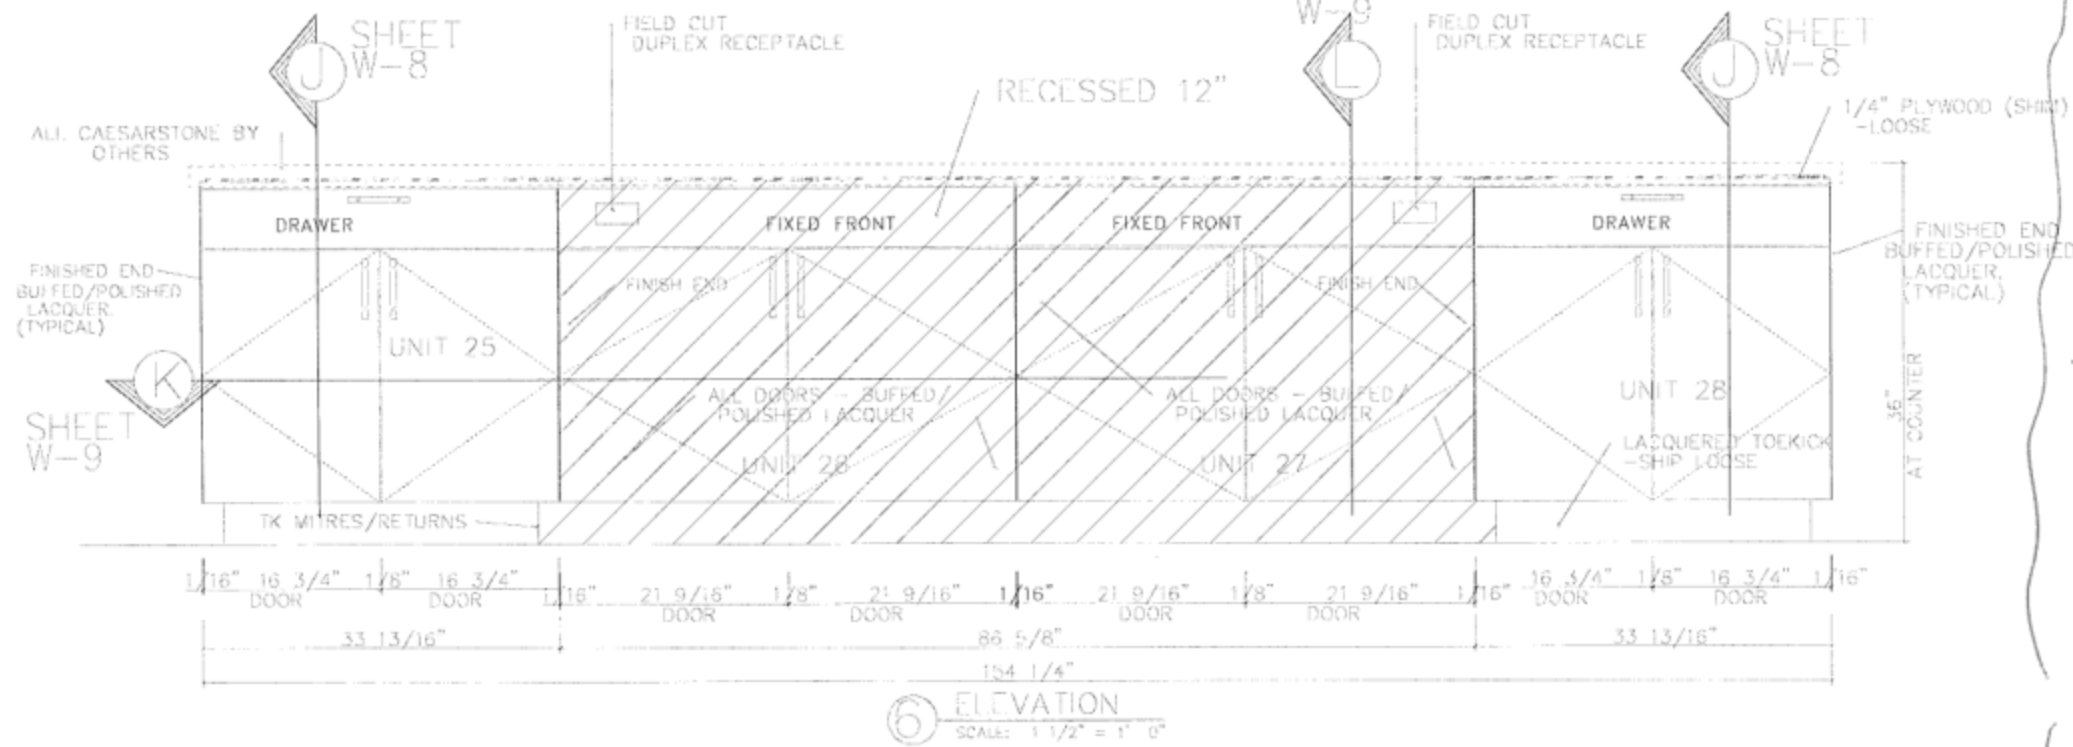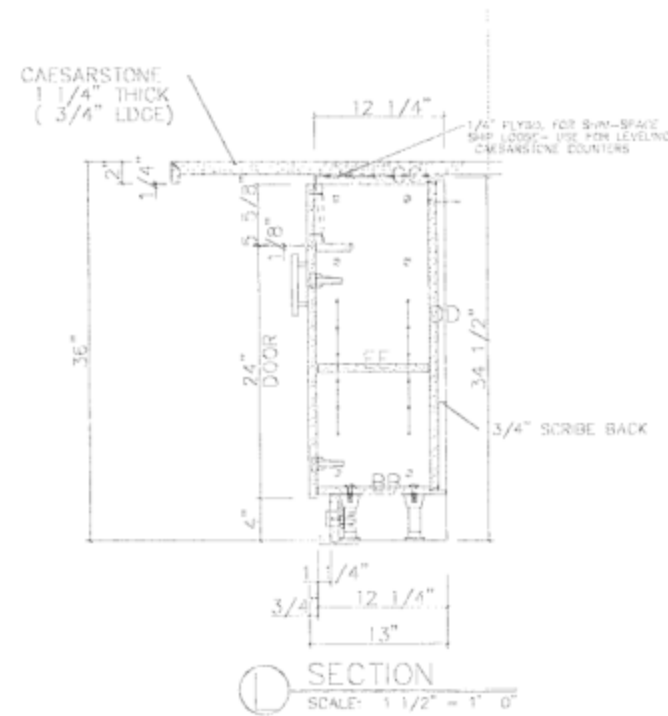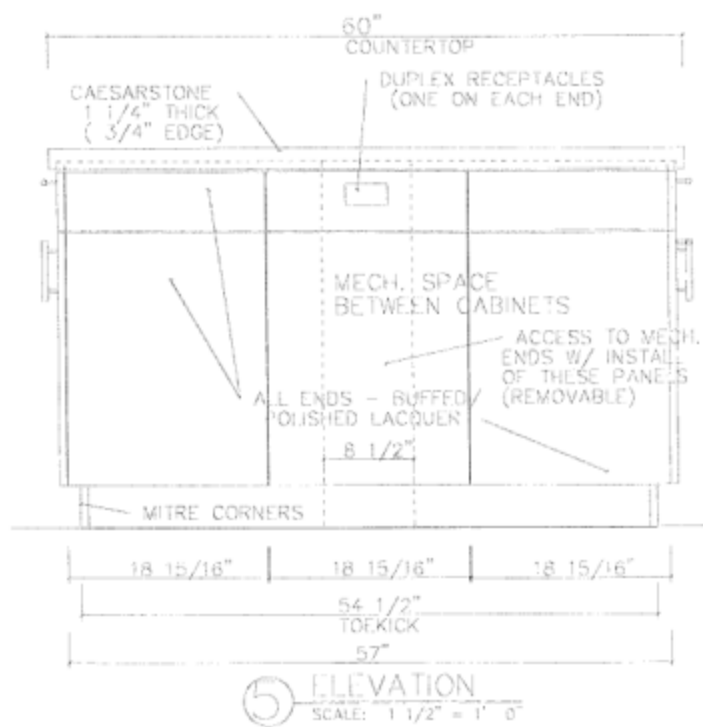

NOTE -- WILL ISLAND BE OK 11 1/4" LONGER? --> CONFIRM W/ OWNER.

DESIGNER APPROVED

ALL CABINET INTERIORS - WHITE MELAMINE
ALL CABN'T EXTERIORS - POLISHED LACQUER

SCALE:	PROJECT: LITTLE ST. JAMES	REVISED:	DATE:
AS NOTED	SHEET TITLE:		10/25/10
DRAWN BY:	ISLAND ELEV./SECTION		SHEET #:
KAS	SHEET 9 OF 9		W-9

PROVIDE DESIGNER W/ FINISH SAMPLES.
FOR APPROVAL - PRIOR TO CONSTRUCTION.
OWNER TO APPROVE SIZE INCREASE
OF ISLAND.

APPROVED AS NOTED 11.10.2010
X MARK ZEFF.